







DESIGNS OF ICE PLANTS

Design/Build/Engineering

Look these pictures over. Sanchez Refrigeration designed and built this entire ice plant. The photos speak for themselves as to the quality, care and efficiency that every Sanchez design has. Please call Ralph to discuss any idea you have, be it new, remodel or expansion.

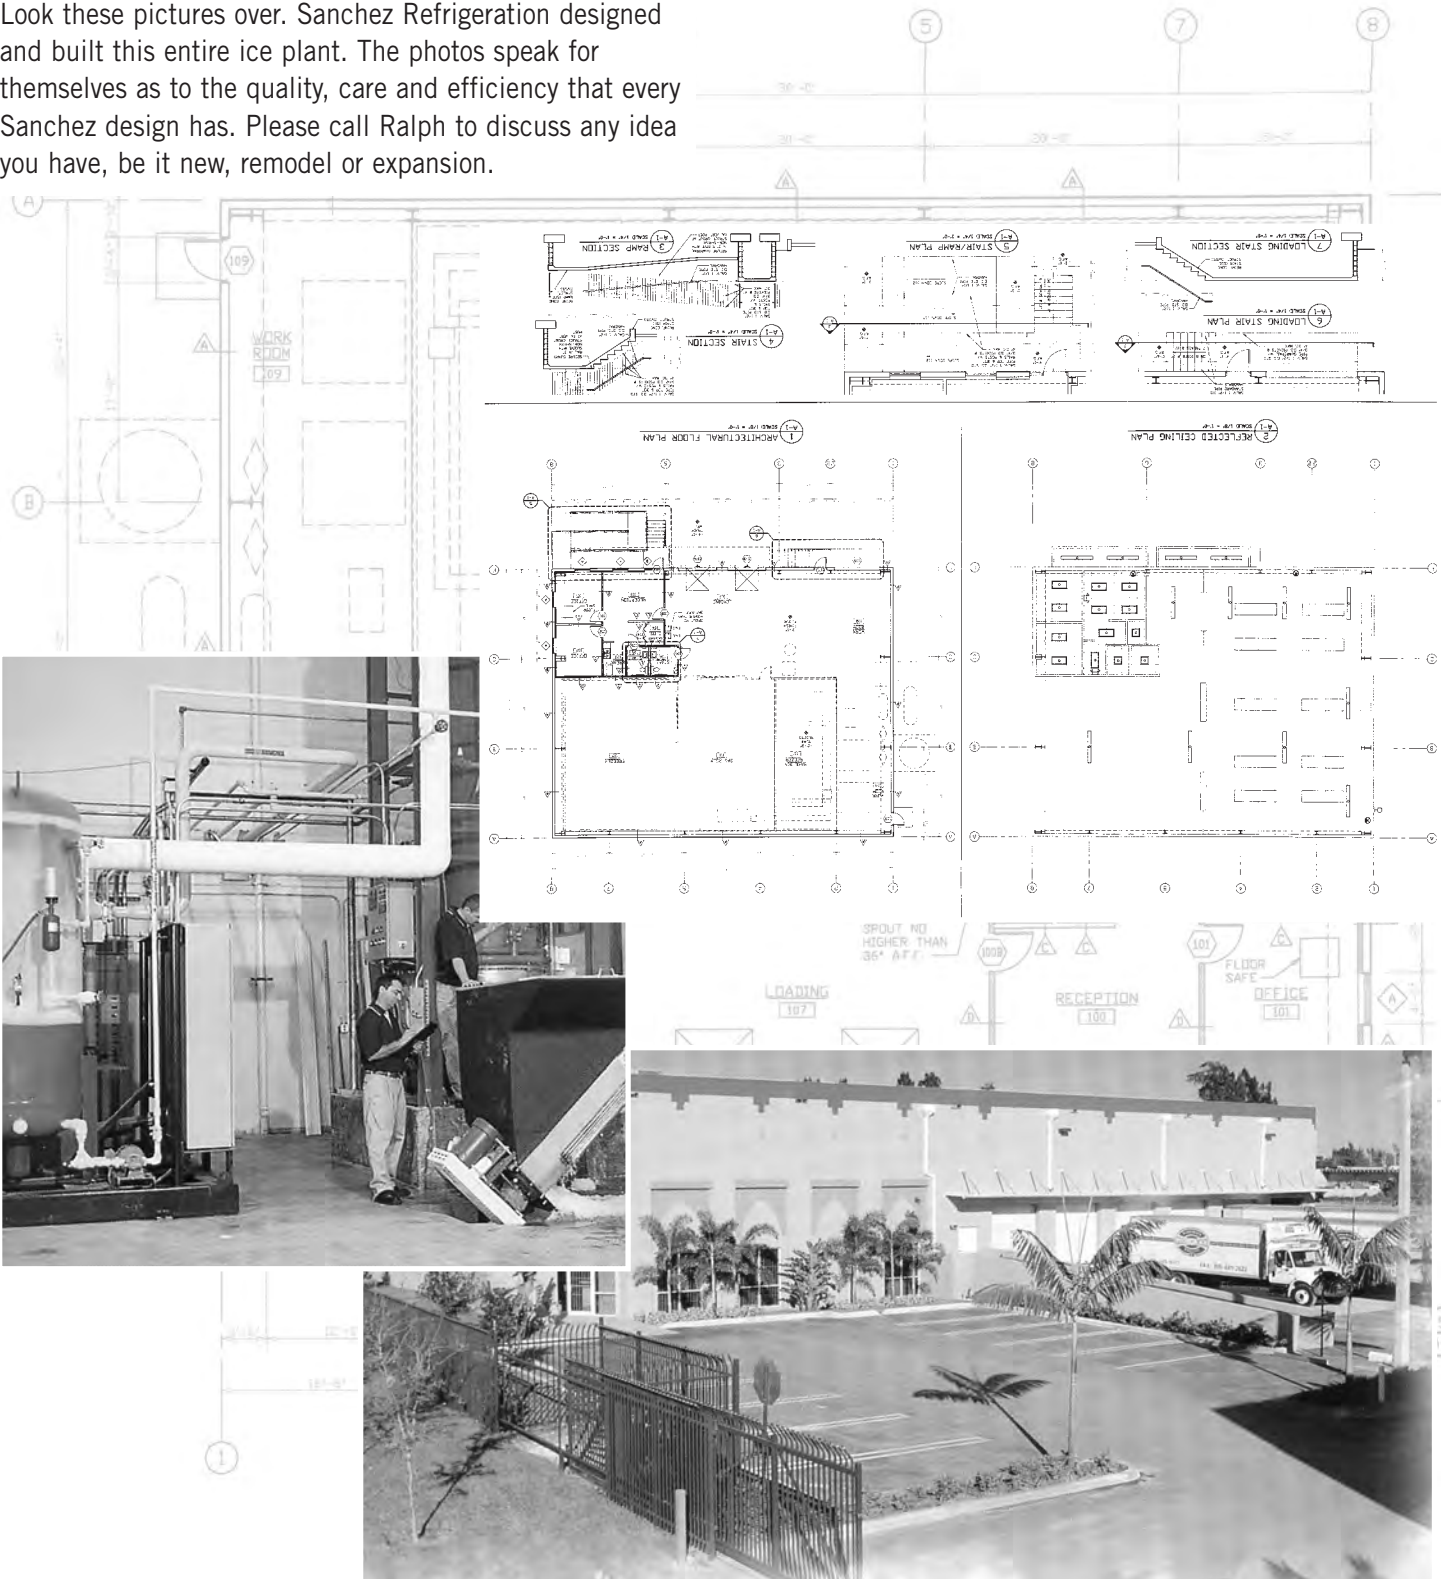

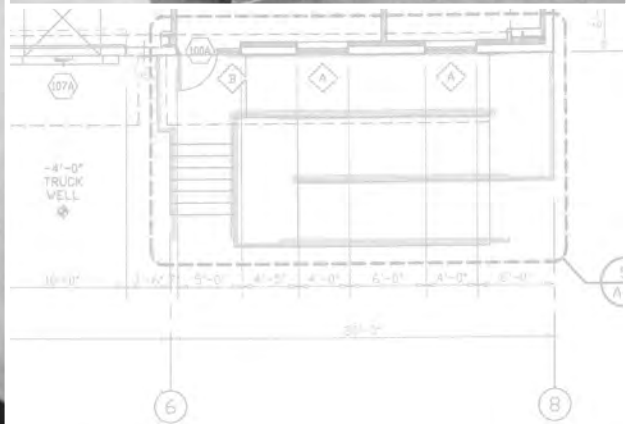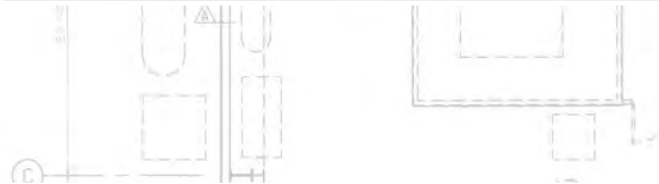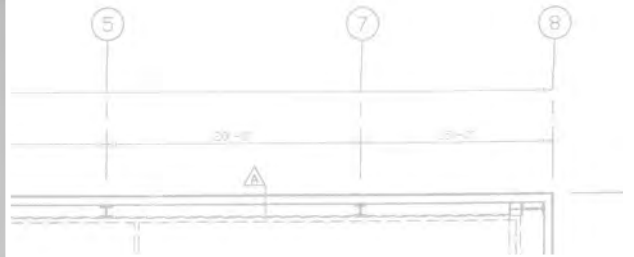

FLOOR PLAN

A-1 SCALE: 1/8" = 1'-0"

